



FED. ROAD DIST. NO.	STATE	FED. AID PROJ. NO.	FISCAL YEAR	SHEET NO.	TOTAL SHEETS
HAWAII	HAW.	STP 05720(1)	2014	32A	145

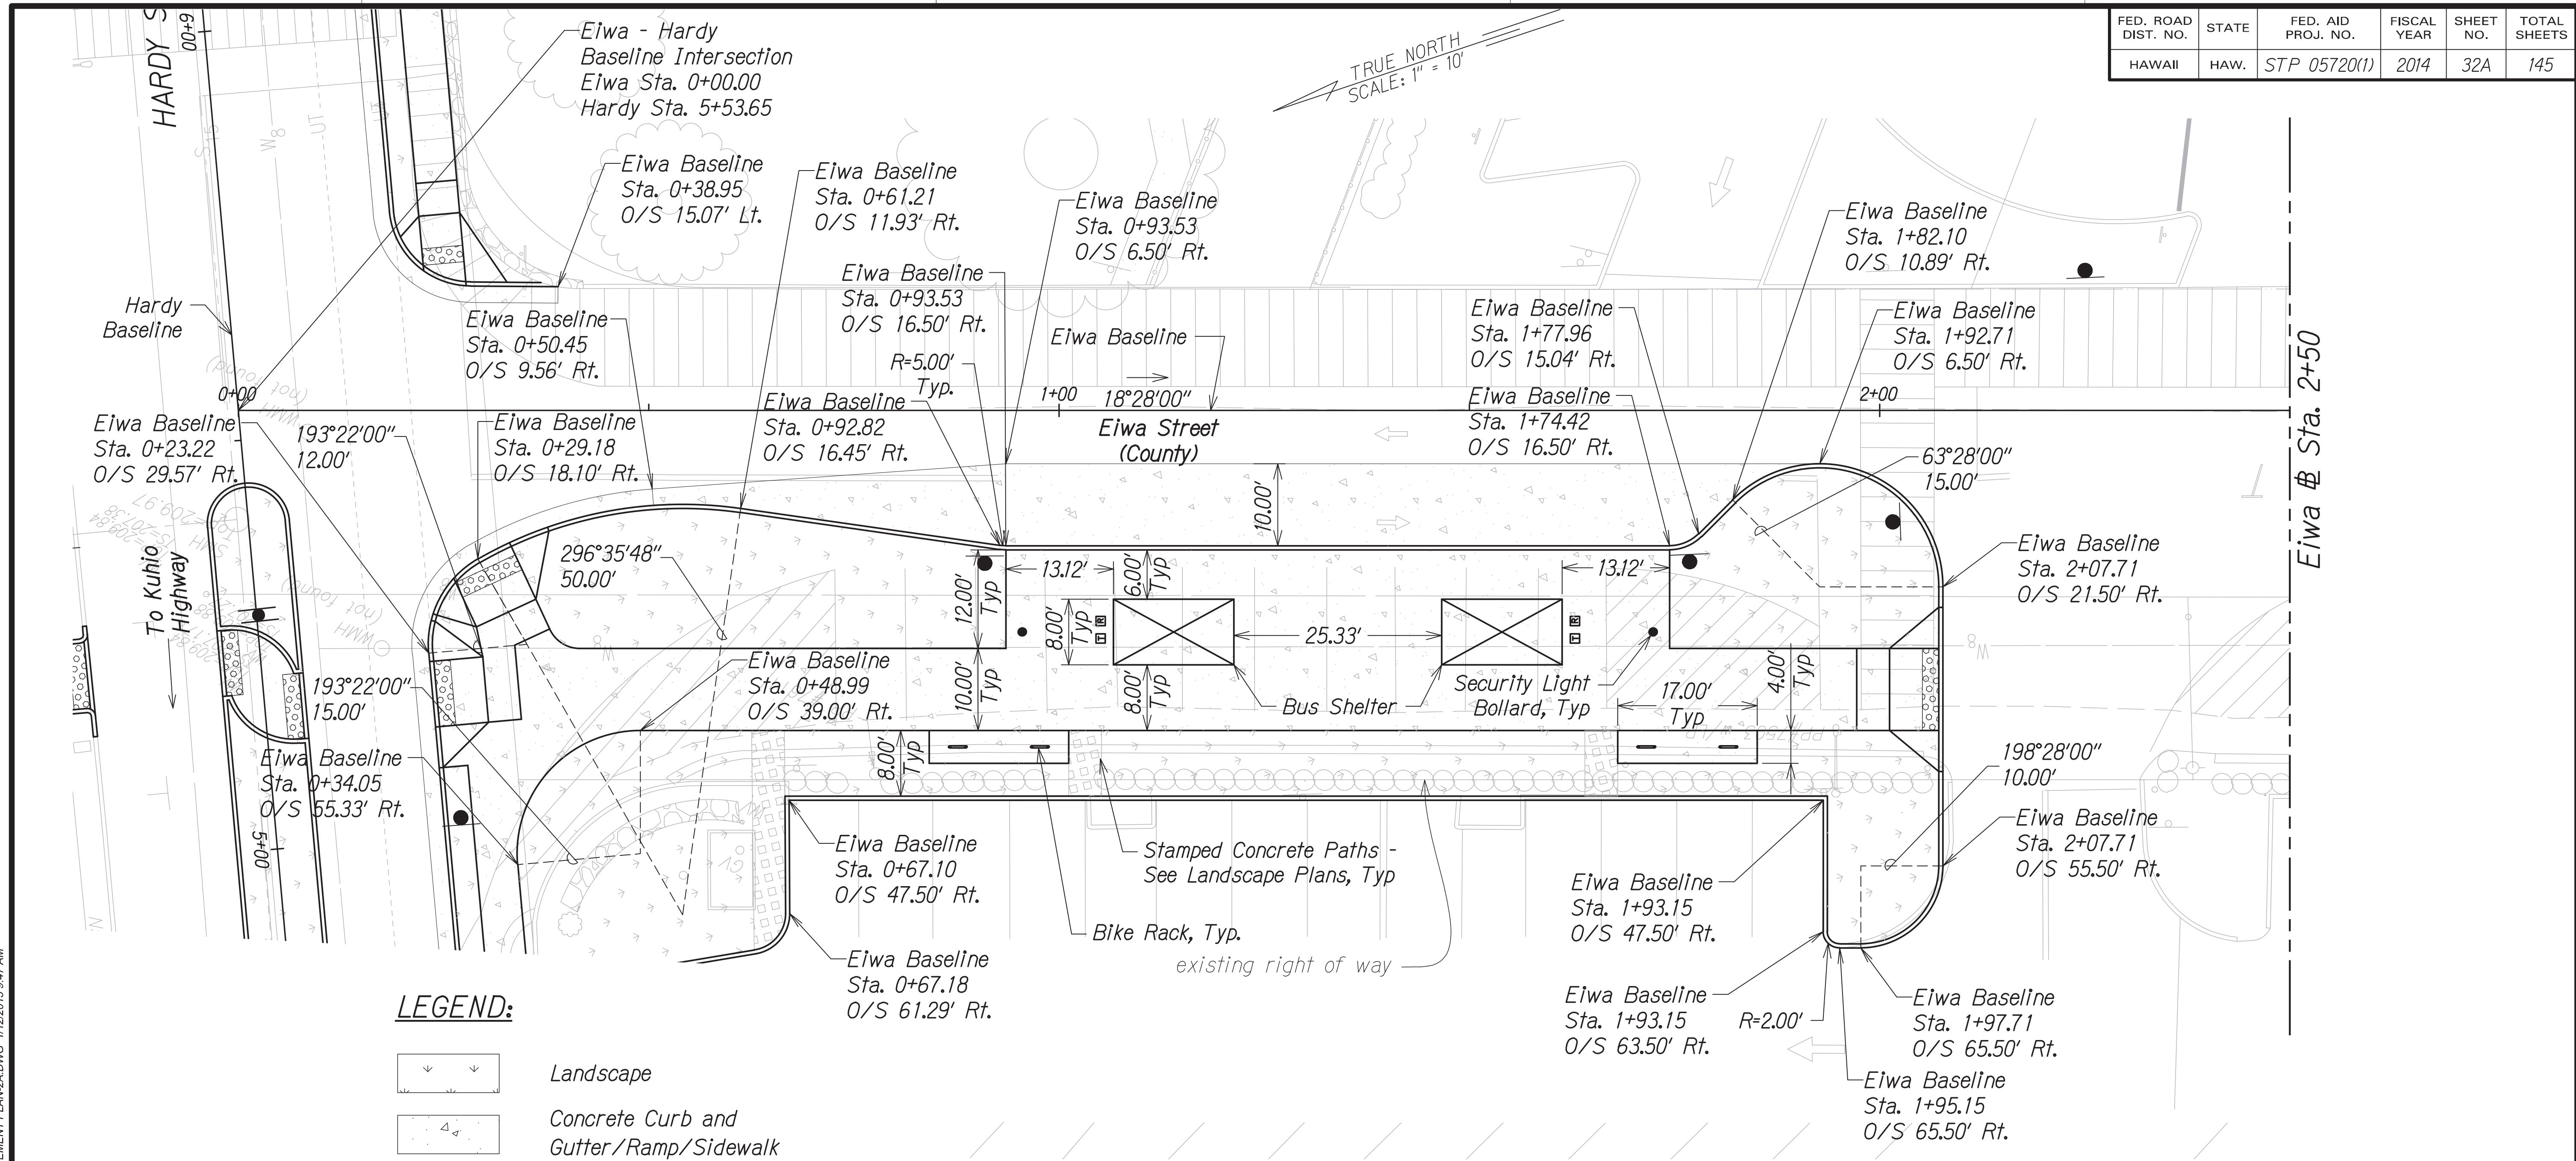


**NOTES:**

1. Provide a smooth transition between the proposed improvements and the existing sidewalks and pavements.
2. See Repaving Plans for pavement improvements.
3. See Water and Sewer Plans for water and sewer improvements.
4. See Drainage Plans for drainage improvements.
5. See Electrical Plans for electrical improvements.
6. See Landscape Plans for landscape improvements.
7. See Sheets 74-84 for Curb Ramp Details.
8. Bus shelter manufacturer shall provide the necessary illumination calculations to confirm the lighting within the shelter provides the required illumination for the adjacent bus loading area.

**GRAPHICAL SCALE:**

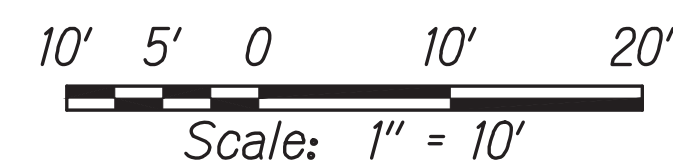

DEPARTMENT OF PUBLIC WORKS  
COUNTY OF KAUAI  
APPROVED:  
\_\_\_\_\_  
COUNTY ENGINEER      DATE

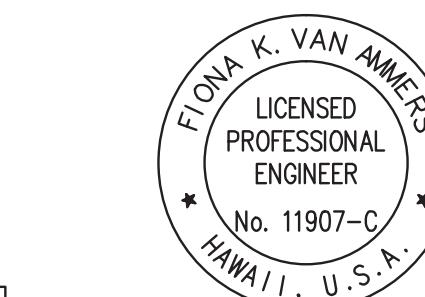

THIS WORK WAS PREPARED BY ME OR UNDER MY SUPERVISION AND CONSTRUCTION OF THIS PROJECT WILL BE UNDER MY OBSERVATION.  
\_\_\_\_\_  
SIGNATURE      APRIL 30, 2016  
EXPIRATION DATE OF THE LICENSE

COUNTY OF KAUAI  
DEPARTMENT OF PUBLIC WORKS  
BUILDING DIVISION

**ROADWAY IMPROVEMENT PLAN**

**HARDY STREET IMPROVEMENTS**  
Federal Aid Project No. STP 05720(1)

Scale: As Noted      Date: May, 2015

SHEET No. 2A OF 7 SHEETS

W:\\_CIVIL\_3D\_PROJECTS\2012\_136.000\_EWP\_HARDY\_STREET\_DB\CIVIL\_DRAWINGS\ROADWAY IMPROVEMENT PLAN-2A.DWG 1/12/2015 9:47 AM